


LANCASTER 7TH DAY ADVENTIST
 CHURCH GYMNASIUM ADDITION
 357 STERLING ROAD
 LANCASTER, MA 01523



SYMBOLS LEGEND

- EXISTING WALL CONSTRUCTION
- INTERIOR BEARING WALL CONSTRUCTION
- NEW WALL CONSTRUCTION 2x4 INTERIOR
2x6 EXTERIOR UNLESS NOTED OTHERWISE
- WALLS/ STRUCTURE TO BE DEMOLISHED
- NEW SPRINKLER HEAD FOR REFERENCE,
SPRINKLER CONTRACTOR TO ENGINEER AND
SUBMIT PLANS AND CALCS
- NEW SIDEWALL SPRINKLER HEAD
- NEW CEILING MT. DETECTION DEVICE
- NEW EMERGENCY EXIT LIGHT BATTERY BACKUP
PER CODE
- NEW EMERGENCY LIGHT TO MATCH EXISTING
- NEW HVAC RETURN
- NEW LINEAR DIFFUSER HVAC SUPPLY
- SINGLE POLE MOTION SENSOR SWITCH WITH A/B
MANUAL OVERRIDE FOR AUTOMATIC LIGHTING
CONTROL TYPICAL THROUGH MOUNTED 42WAF
(3 THREE WAY SWITCH)
- NEW EXTERIOR RATED WALL MOUNTED LIGHT
- NEW PENDANT LIGHT FIXTURE
- NEW LED RECESSED CAN LIGHT
- WALL TYPE SEE SHEET A1.08 FOR DETAIL INFO
- HORN/STROBE UNIT
- FIRE ALARM PULL STATION

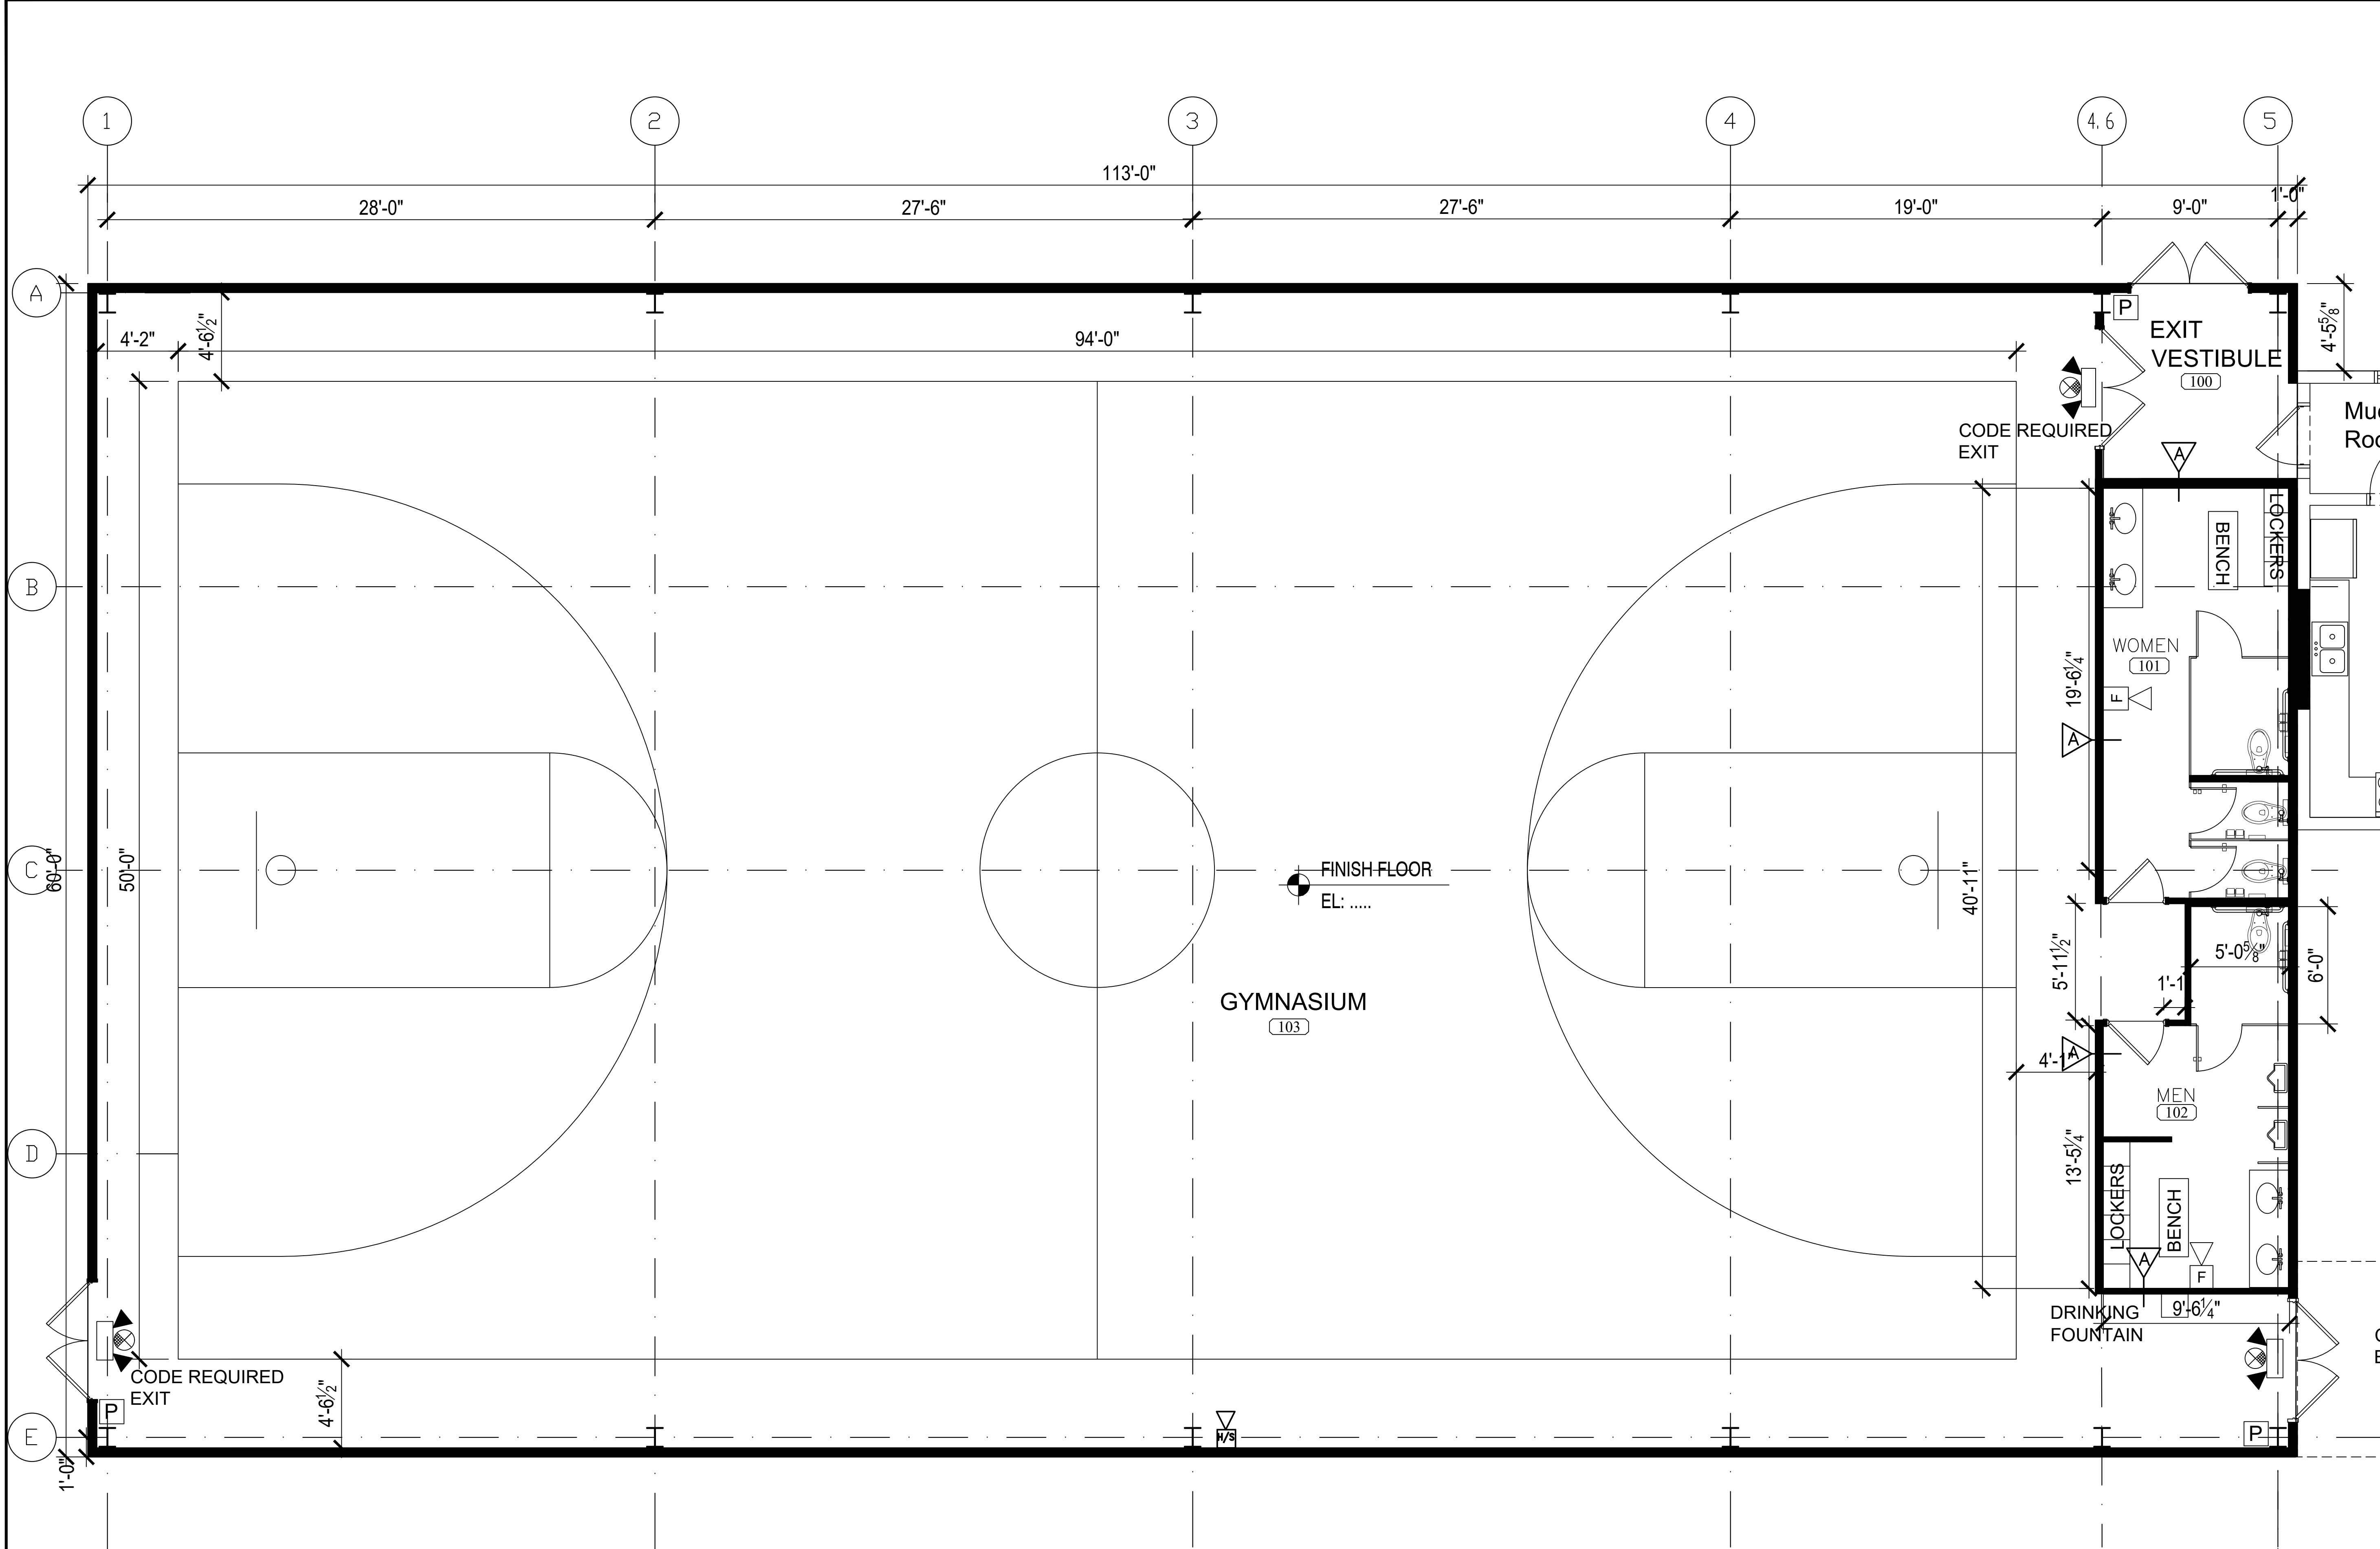

ARCHITECT:
 Mark Schryver
 370 Goss Lane
 Lancaster, MA 01523
 ph. (978) 844-4708

DATE : 7.21.23

ENLARGED FLOOR PLAN

SCALE: 1/4"=1'-0"

PERMIT SET	A2
------------	----